

FIXTURE LEGEND

ptd Paper towel dispenser

LIGHTING LEGEND

- Single light switch
- Surface mounted twin 1200mm fluoro with di
- Surface mounted circular fluoro.
- △ Wall mounted external light fitting
- ⊙ Smoke detector
- ⊙ Exhaust fan

ELECTRICAL LEGEND

- ⚡ Double GPO 300mm AFL UNO
- ⚡ Single GPO 300mm AFL UNO
- ⚡wp Weatherproof double GPO 300mm AFL UNO
- ⚡wp Weatherproof single GPO 300mm AFL UNO
- ▽ Tel / Fax outlet
- ⬛ Switchboard with lockable circuit breakers


DOOR SCHEDULE

| Number | Size (h x w) | Comments |
|--------|--------------|----------------------------|
| D1 | 2040 x 1500 | Alum. framed sliding door |
| | 2040 x 720 | Timber framed sliding door |


WINDOW SCHEDULE

| Number | Size (h x w) | Comments |
|--------|---------------|--|
| W1 | 600 x 600 | Alum. framed sliding selected colour + PV, OBS glass |
| W2 | 1,000 x 1,200 | Alum. framed sliding selected colour |

Floor Plan
Scale 1:50

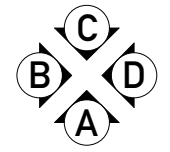


Elevation Key

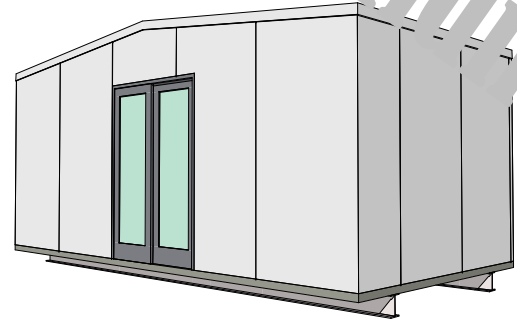


SKETCH FOR CLIENTS APPROVAL

Client Approval :


| | | | | | |
|---|--|-----------------------------|------------------------------|---------------------------------------|----------------------------|
| <p>Trident Transportable Buildings (Aust) Pty Ltd <i>Custom made transportable buildings. Features you expect, service you deserve.</i></p> <p>ABN : 61 149 077 369 BSA No. :XXXXXX 184 North Road, Woodridge QLD 4114 Phone 0415 039 064</p> <p>© Copyright</p> | <p>Project: 6 x 3.15m ROOM + ENSUITE AT</p> | <p>Client:</p> | | <p>Drawing Title: PLAN</p> | |
| | <p>Notes: - CONTRACTOR to verify all dimensions prior commencing any work - All electrical work to relevant Australian Standards and BCA requirements. - Client to confirm selection of all fixtures prior to installation. - Contractor to confirm with client on final location of all fixtures.</p> | <p>Job No: 13-000</p> | <p>Date: JULY . 2013</p> | <p>Drawing No: SK01</p> | <p>Issue: A</p> |
| | | <p>Scale: 1:50 @ A4</p> | <p>Drawn S.B.</p> | | |

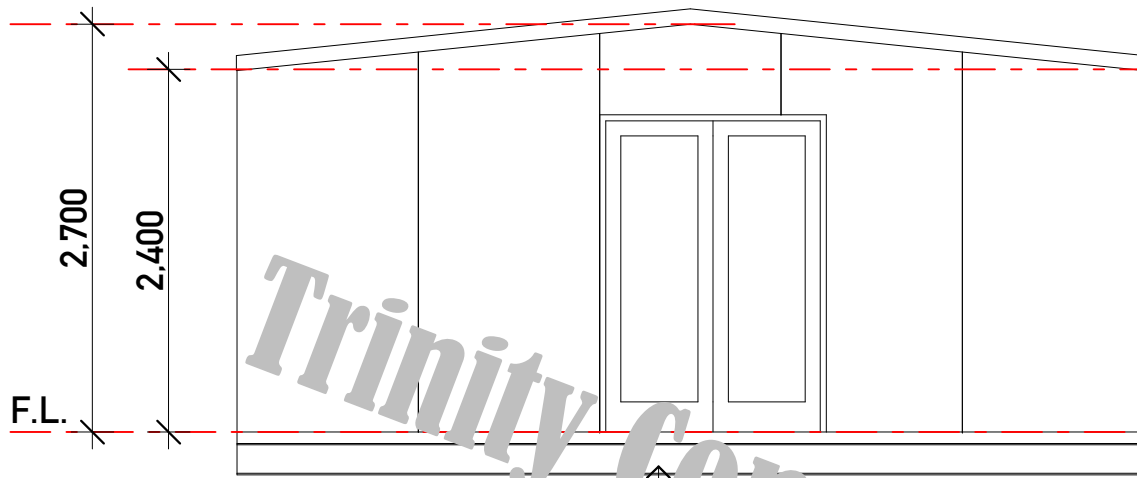


Elevation A
Scale 1:50

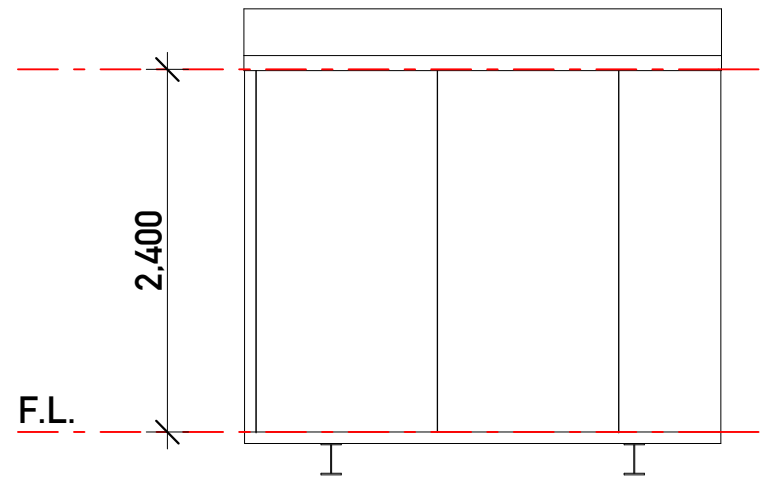

Elevation B
Scale 1:50

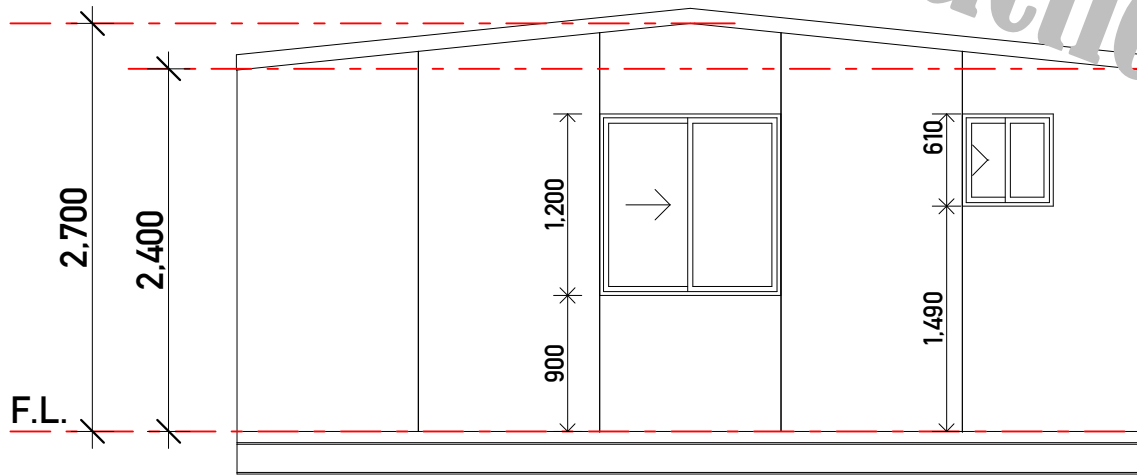

Elevation C
Scale 1:50

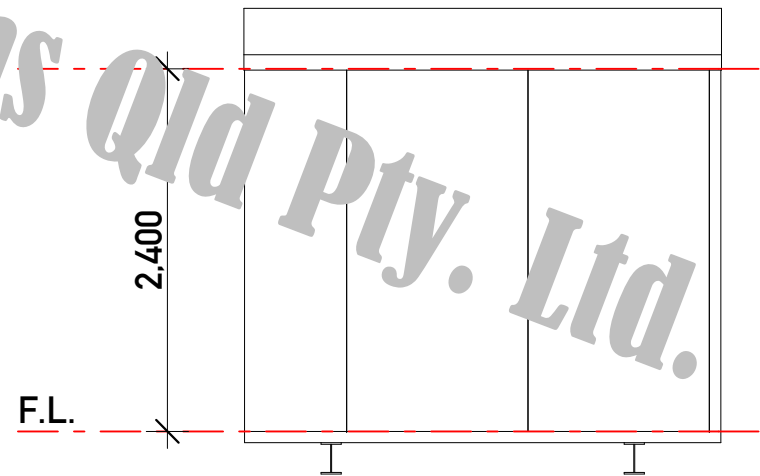

Elevation D
Scale 1:50

SKETCH FOR CLIENTS APPROVAL

Client Approval :



Trident Transportable Buildings (Aust) Pty Ltd

Custom made transportable buildings. Features you expect, service you deserve.

ABN : 61 149 077 369
BSA No. :XXXXXX
184 North Road,
Woodridge QLD 4114
Phone 0415 039 064

©Copyright

Project:
6 x 3.15m ROOM + ENSUITE
AT

Notes:
- CONTRACTOR to verify all dimensions prior commencing any work
- All electrical work to relevant Australian Standards and BCA requirements.
- Client to confirm selection of all fixtures prior to installation.
- Contractor to confirm with client on final location of all fixtures.

Client:

Job No:
13-000

Scale:

Date:
JULY . 2013

Drawn
S.B.

Drawing Title:
ELEVATIONS

Drawing No:

SK02

Issue:

A