

**Floor Plan**  
Scale 1:100



Elevation Key

**LIGHTING LEGEND**

- Single light switch
- Fan controller
- Surface mounted single 1200mm fluoro with diffuser
- Surface mounted circular fluoro.
- Wall mounted external light fitting
- Smoke detector
- Exhaust fan
- 900mm dia. ceiling fan

**ELECTRICAL LEGEND**

- Double GPO 300mm AFL UNO
- Single GPO 300mm AFL UNO
- Tel / Fax outlet
- Coaxial TV outlet from aerial
- Switchboard
- Power entry box

**DOOR SCHEDULE**


Number	Size (h x w)	Comments
D1	2100 x 1800	Alum. framed sliding, selected colour
D2	2040 x 770	Timber door painted
D3	2040 x 770	Face sliding, timber door painted

**WINDOW SCHEDULE**


Number	Size (h x w)	Comments
W1	1210 x 1200	Alum. framed sliding, selected colour
W2	1210 x 1200	Alum. framed sliding, selected colour
W3	1210 x 1200	Alum. framed sliding, selected colour
W4	610 x 600	Alum. framed sliding + PV/OBS, selected colour

Client Approval : .....


<p><b>Trident Transportable Buildings (Aust) Pty Ltd</b> Custom made transportable buildings. Features you expect, service you deserve.</p> <p>ABN : 61 149 077 369 BSA No. :XXXXXX 184 North Road, Woodridge QLD 4114 Phone 0415 039 064</p> <p>© Copyright</p>	<p>Project: <b>STANDARD 9.6 x 3.4 CABIN AT</b></p>	<p>Client:</p>		<p>Drawing with <b>PLAN</b></p>	
	<p>Notes: - CONTRACTOR to verify all dimensions prior commencing any work - All electrical work to relevant Australian Standards and BCA requirements. - Client to confirm selection of all fixtures prior to installation. - Contractor to confirm with client on final location of all fixtures.</p>	<p>Job No: 10-000</p>	<p>Date: MAY 2010</p>	<p>Drawing No:</p>	<p>Issue: <b>A</b></p>
		<p>Scale: 1:100 @ A4</p>	<p>Drawn S.B.</p>	<p><b>SK01</b></p>	

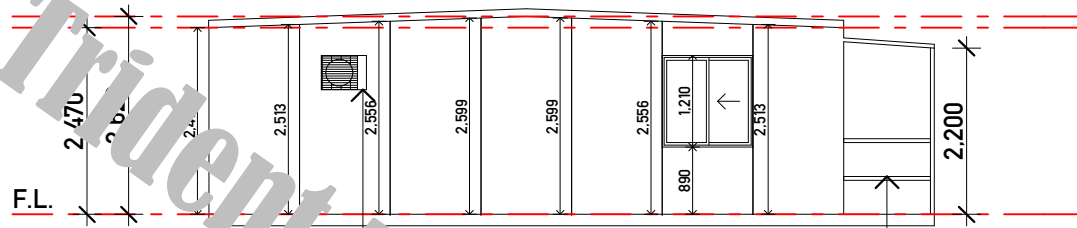


**Elevation A**  
Scale 1:100

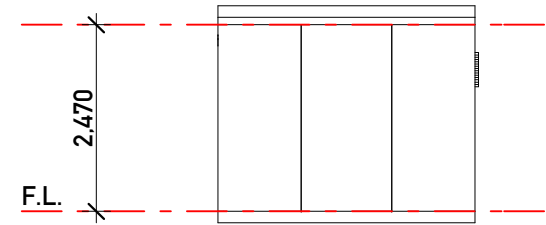


**Elevation B**  
Scale 1:100

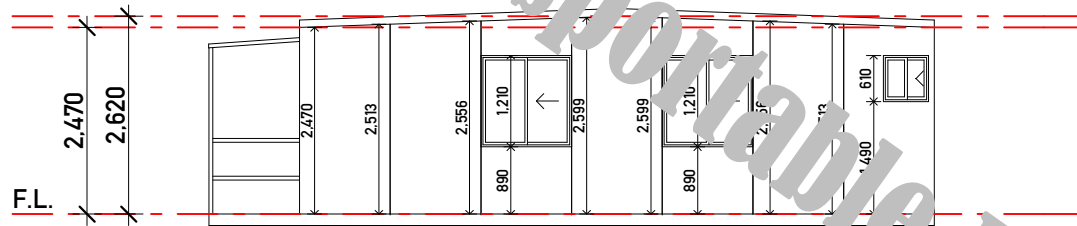


**Elevation C**  
Scale 1:100

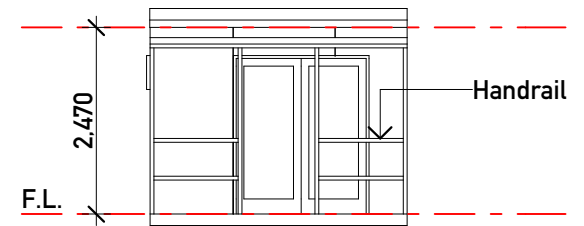

**Elevation D**  
Scale 1:100

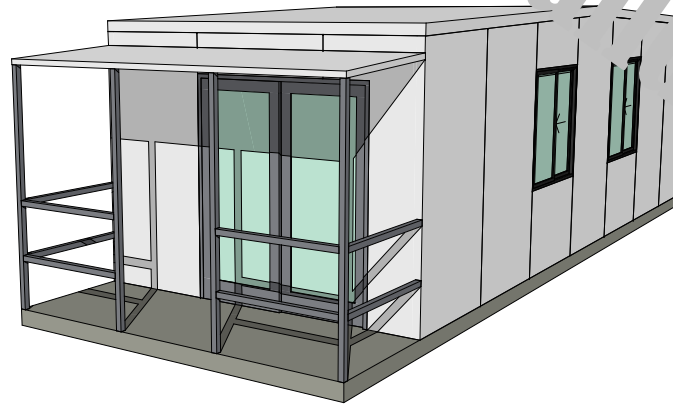

Client Approval: .....

 <p><b>Trident Transportable Buildings (Aust) Pty Ltd</b> <i>Custom made transportable buildings. Features you expect, service you deserve.</i></p> <p>ABN : 61 149 077 369 BSA No. :XXXXXX 184 North Road, Woodridge QLD 4114 Phone 0415 039 064</p> <p>© Copyright</p>	<p>Project: <b>STANDARD 9.6 x 3.4 CABIN AT</b></p>	<p>Client:</p>		<p>Drawing Title: <b>ELEVATIONS</b></p>	
	<p>Notes:</p> <ul style="list-style-type: none"> <li>- CONTRACTOR to verify all dimensions prior commencing any work</li> <li>- All electrical work to relevant Australian Standards and BCA requirements.</li> <li>- Client to confirm selection of all fixtures prior to installation.</li> <li>- Contractor to confirm with client on final location of all fixtures.</li> </ul>	<p>Job No: 10-000</p>	<p>Date: MAY 2010</p>	<p>Drawing No: _____ Issue: _____</p>	
		<p>Scale: 1:100 @ A4</p>	<p>Drawn S.B.</p>	<p><b>SK02</b> <b>A</b></p>	