

Floor Plan
Scale 1:100



LIGHTING LEGEND

- Single light switch
- Fan controller
- Surface mounted twin 1200mm fluoro with diffuser
- Surface mounted circular fluoro.
- Wall mounted external light fitting
- Smoke detector
- Exhaust fan
- 900mm dia. ceiling fan

ELECTRICAL LEGEND

- Double GPO 300mm AFL UNO
- Single GPO 300mm AFL UNO
- Tel / Fax outlet
- Coaxial TV outlet from aerial
- Switchboard
- Power entry box

DOOR SCHEDULE

Number	Size (h x w)	Comments
D1	2100 x 1800	Alum. framed sliding door, selected colour
D2	2040 x 820	Timber door painted
D3	2040 x 720	Timber door painted
D4	2040 x 820	Timber door painted


WINDOW SCHEDULE

Number	Size (h x w)	Comments
W1	1210 x 1200	Alum. framed sliding, selected colour
W2	1210 x 1200	Alum. framed sliding, selected colour
W3	610 x 1200	Alum. framed sliding + PV/OBS, selected colour
W4	1210 x 1200	Alum. framed sliding, selected colour


SKETCH FOR CLIENTS APPROVAL

Client Approval :


<p>Trident Transportable Buildings (Aust) Pty Ltd Custom made transportable buildings. Features you expect, service you deserve.</p> <p>ABN : 61 149 077 369 BSA No. :XXXXXX 184 North Road, Woodridge QLD 4114 Phone 0415 039 064</p> <p>© Copyright</p>	<p>Project: 2 BED CABIN 12 x 3.15 AT</p>	<p>Client:</p>		<p>Drawing Title: PLAN</p>	
	<p>Notes:</p> <ul style="list-style-type: none"> - CONTRACTOR to verify all dimensions prior commencing any work - All electrical work to relevant Australian Standards and BCA requirements. - Client to confirm selection of all fixtures prior to installation. - Contractor to confirm with client on final location of all fixtures. 	<p>Job No: 11-</p>	<p>Date: MAY 2010</p>	<p>Drawing No:</p>	<p>Issue:</p>
		<p>Scale: 1:100 @ A4</p>	<p>Drawn S.B.</p>	<p>SK01</p>	<p>A</p>

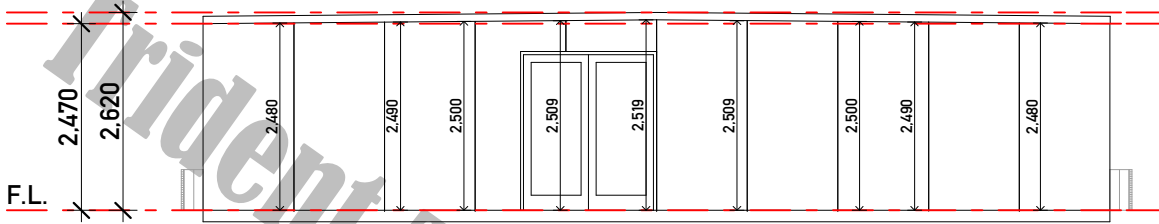


Elevation A
Scale 1:100

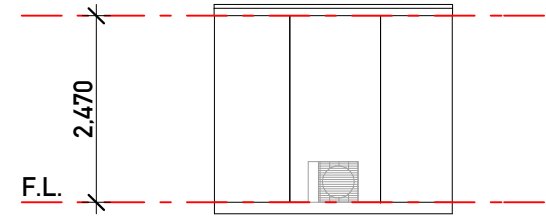


Elevation B
Scale 1:100

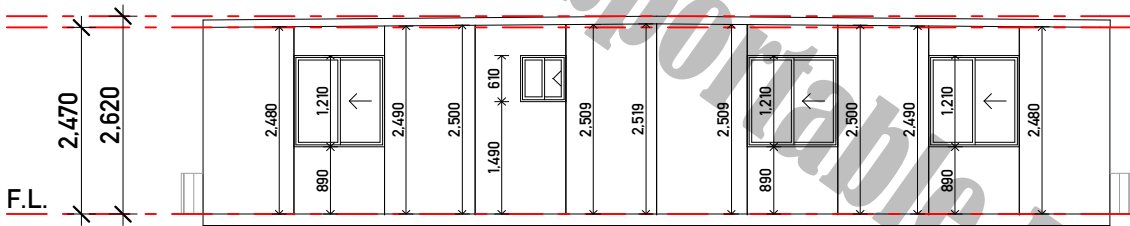

Elevation C
Scale 1:100

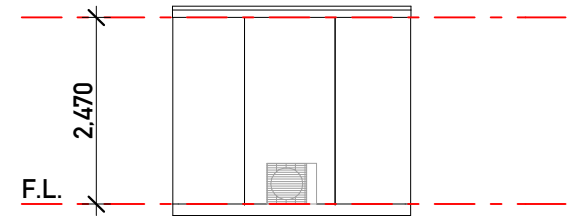


Elevation D
Scale 1:100

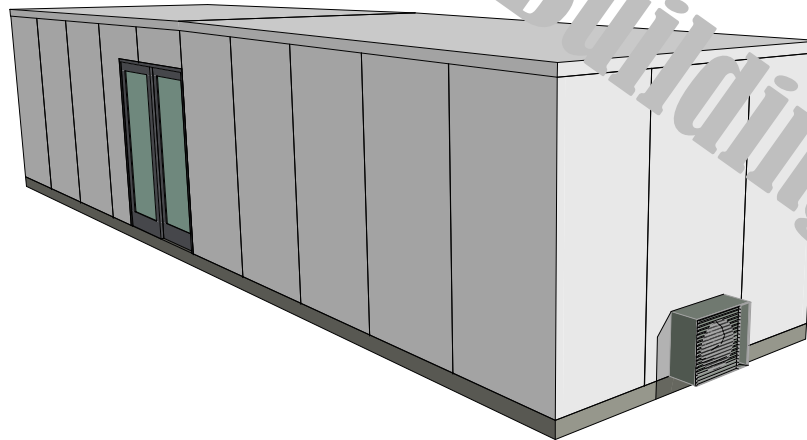

SKETCH FOR CLIENTS APPROVAL

Client Approval :

 <p>Trident Transportable Buildings (Aust) Pty Ltd <i>Custom made transportable buildings. Features you expect, service you deserve.</i></p> <p>ABN : 61 149 077 369 BSA No. :XXXXXX 184 North Road, Woodridge QLD 4114 Phone 0415 039 064</p> <p>© Copyright</p>	<p>Project: 2 BED CABIN 12 x 3.15 AT</p>	<p>Client:</p>		<p>Drawing Title: ELEVATIONS</p>		
	<p>Notes: - CONTRACTOR to verify all dimensions prior commencing any work - All electrical work to relevant Australian Standards and BCA requirements. - Client to confirm selection of all fixtures prior to installation. - Contractor to confirm with client on final location of all fixtures.</p>	<p>Job No: 11-</p>	<p>Date: MAY 2010</p>	<p>Drawing No: _____ Issue: A</p>		
		<p>Scale: 1:100 @ A4</p>	<p>Drawn S.B.</p>	<p>SK02</p>		